






EXISTING PLAN, ELEVATIONS AND SITE PLAN @SCALE 1:100, 1:200 AND 1:1250

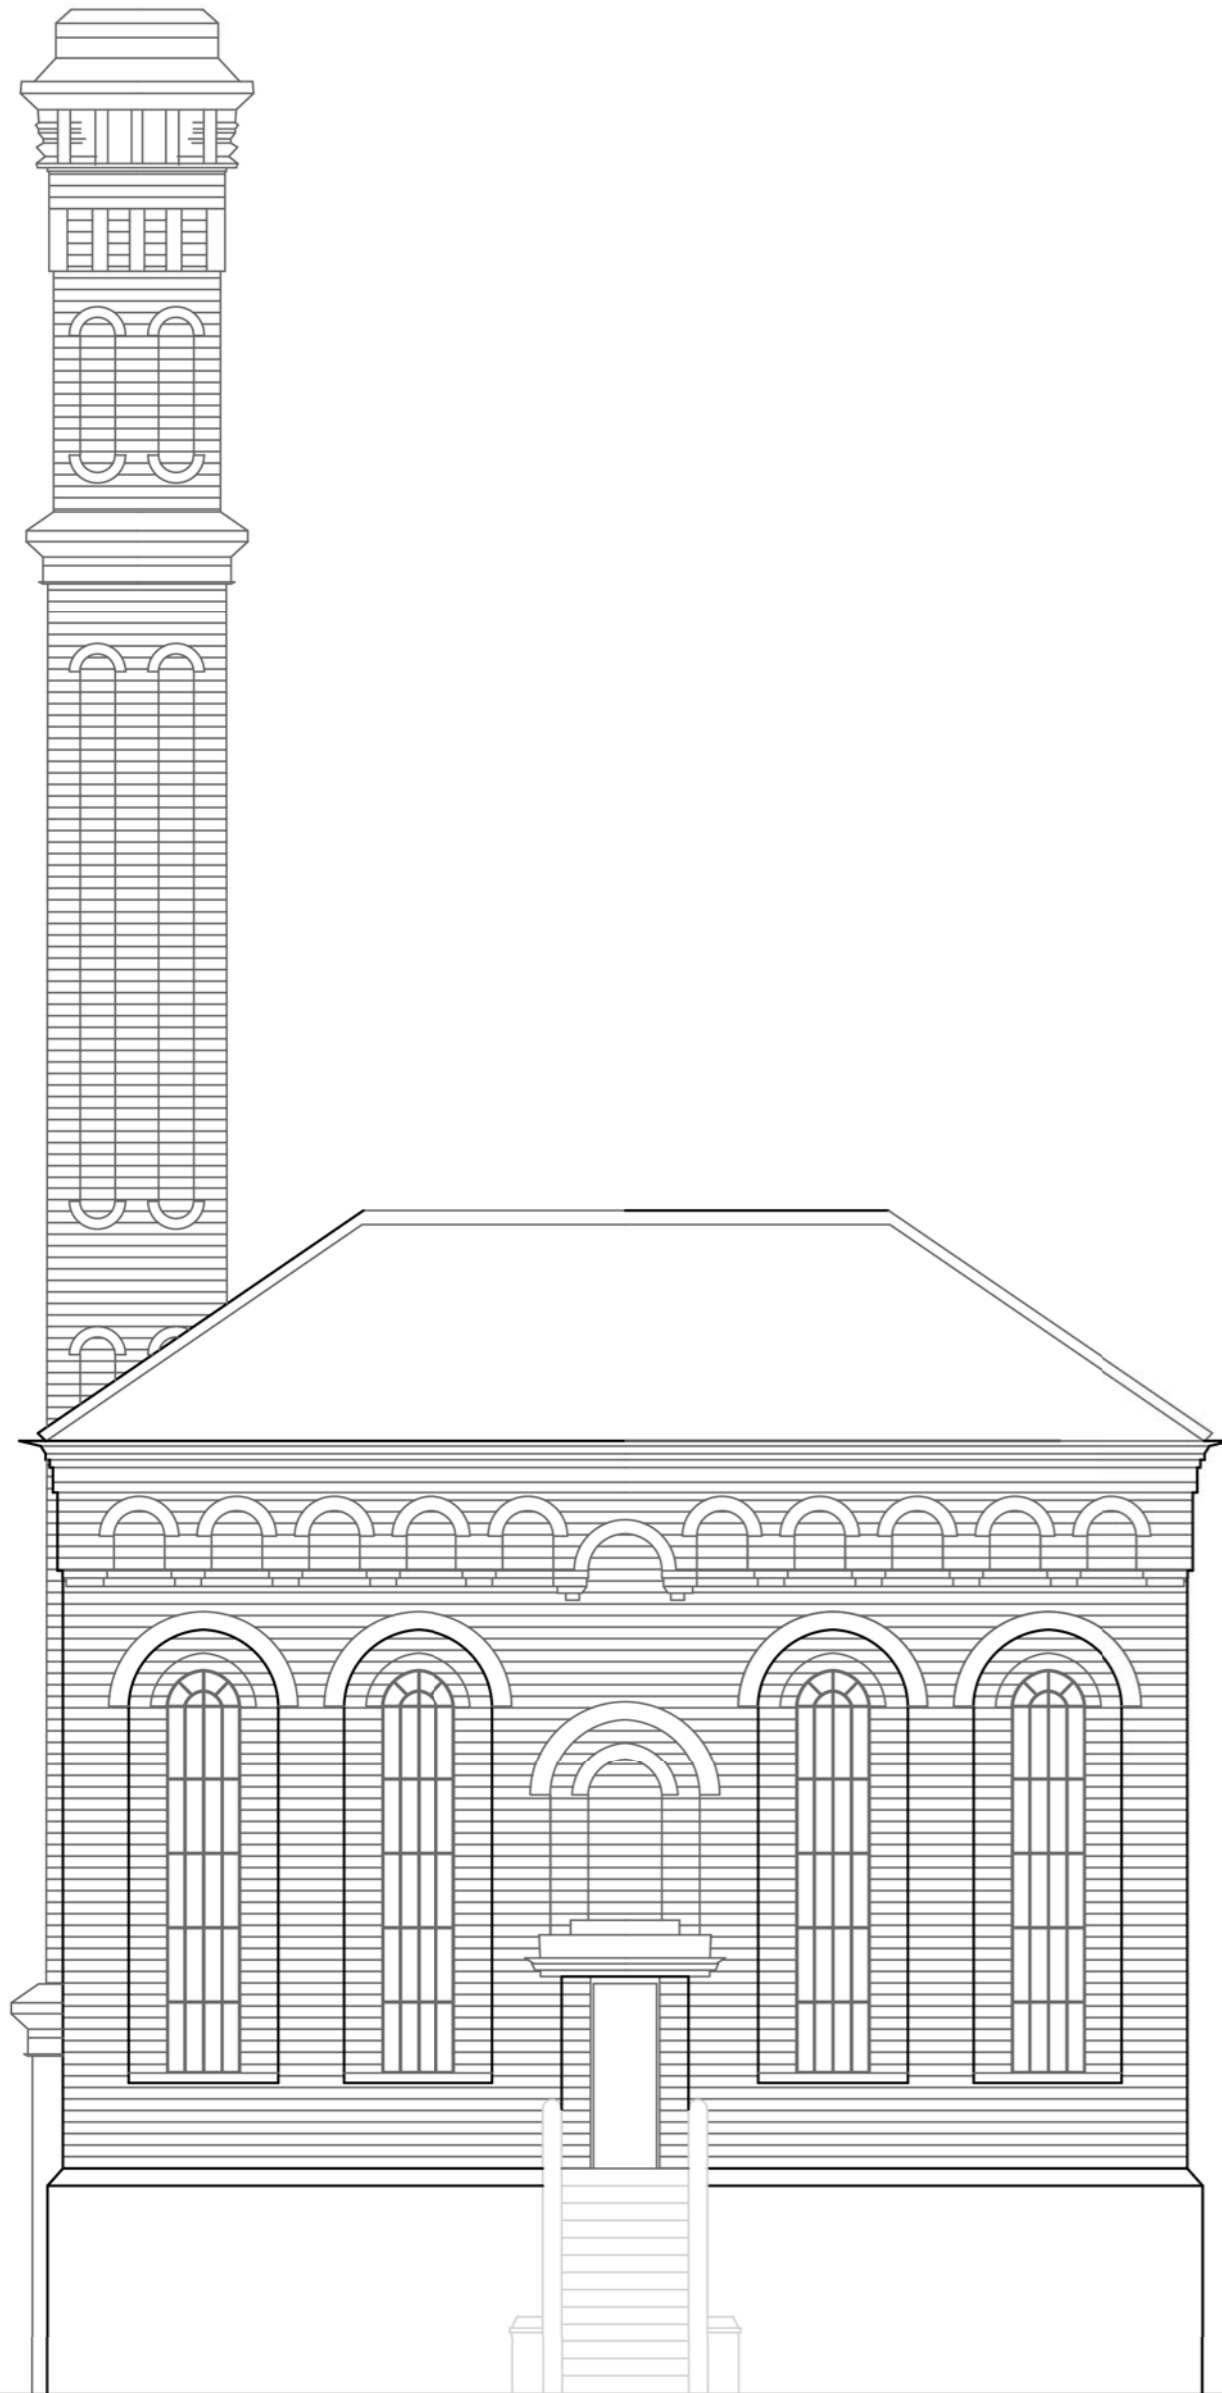


WEST ELEVATION @SCALE 1:100

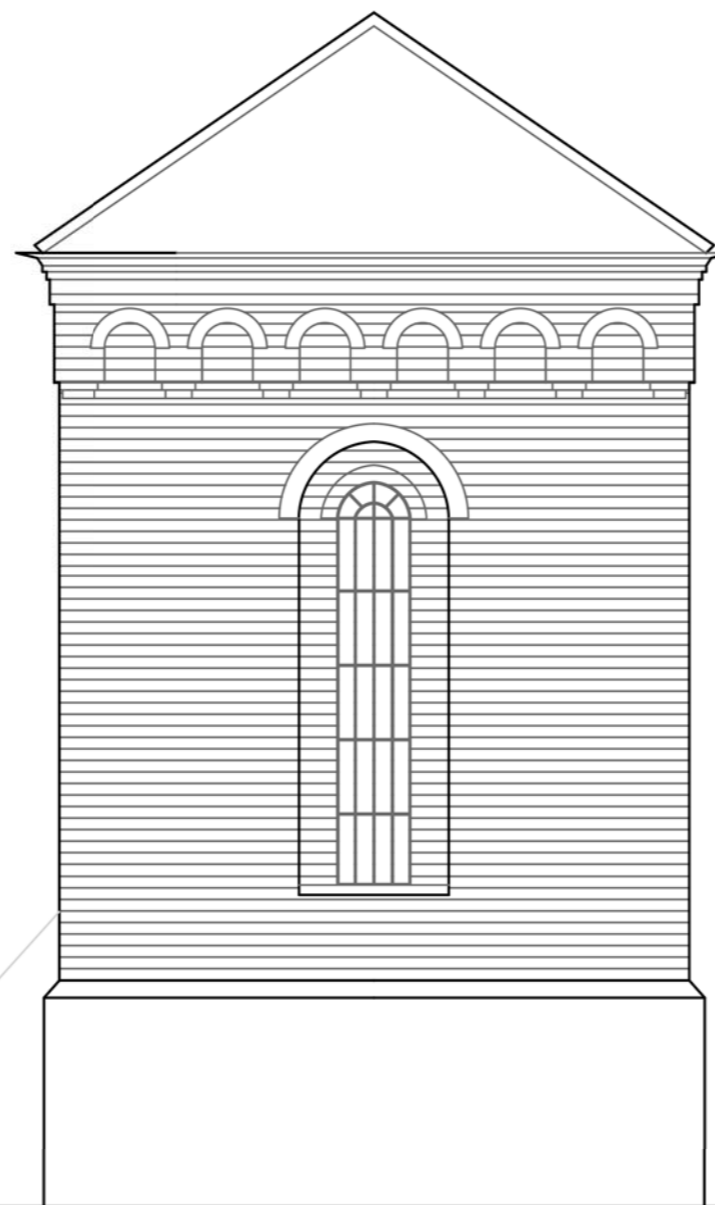


NORTH ELEVATION @SCALE 1:100

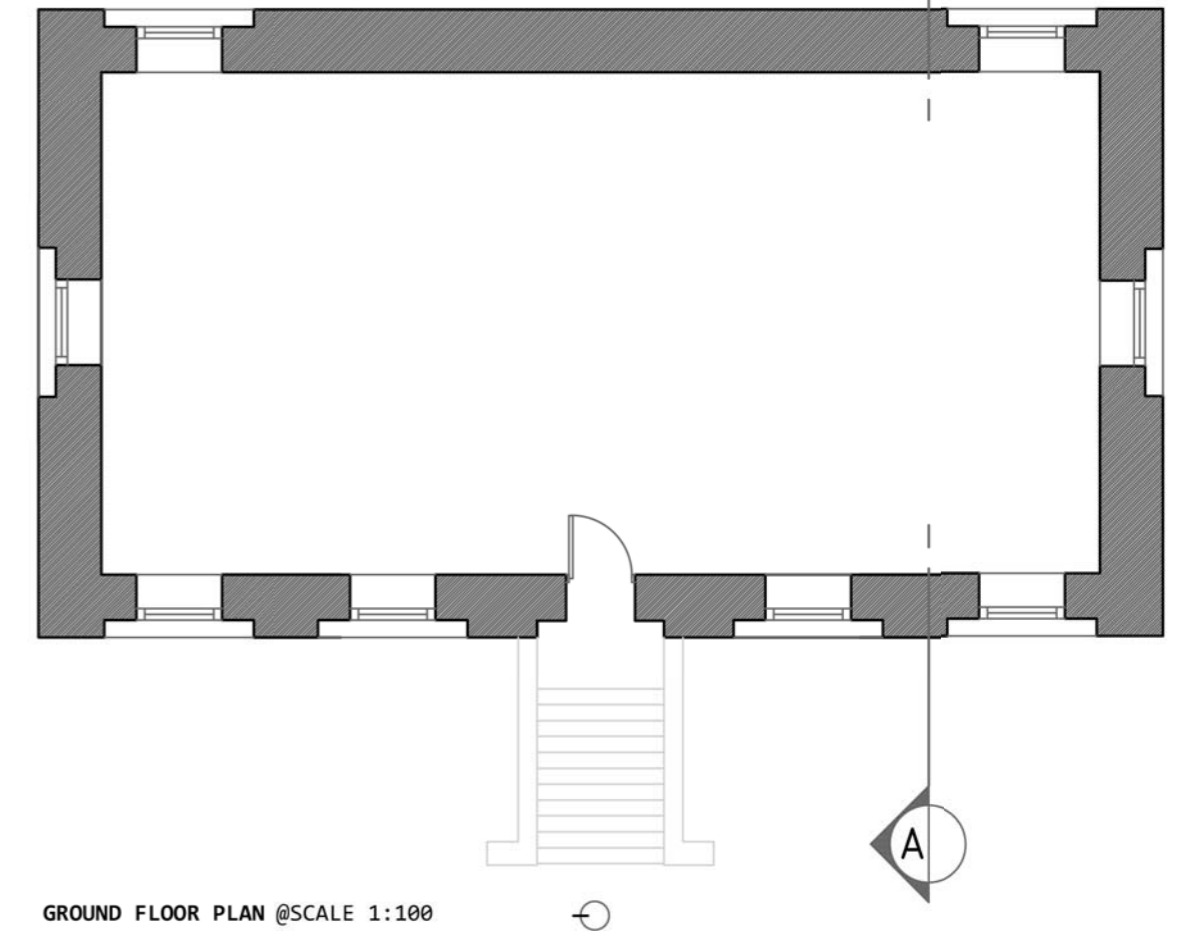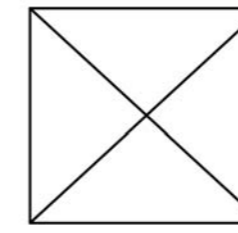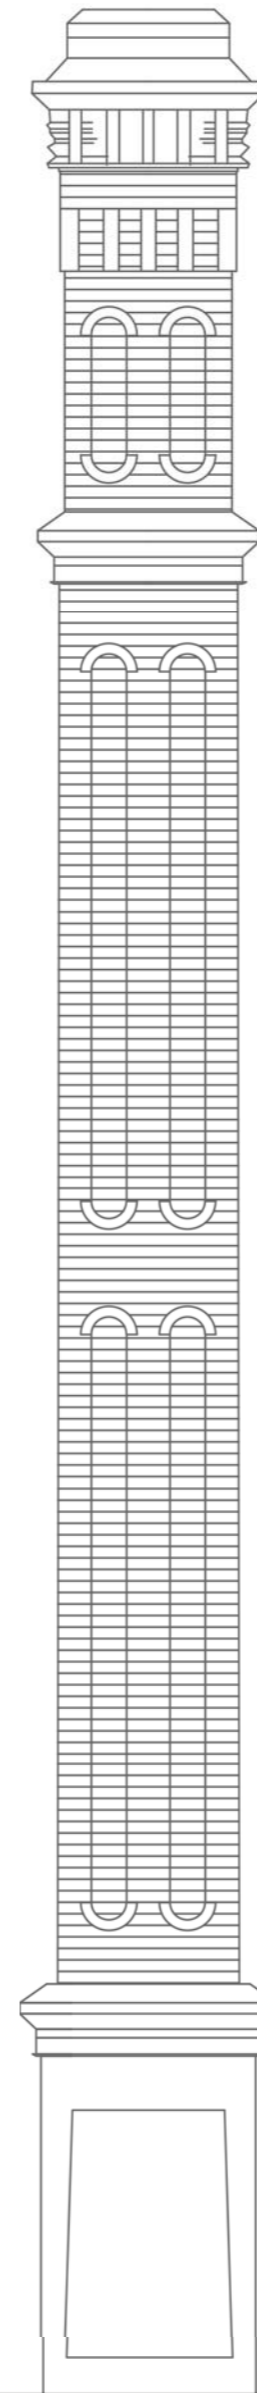

GROUND FLOOR PLAN @SCALE 1:100

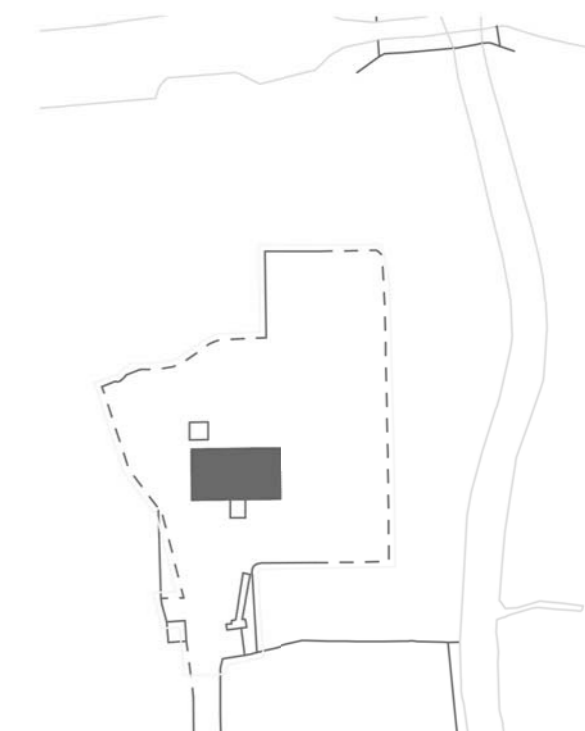

SITE PLAN @SCALE 1:1250

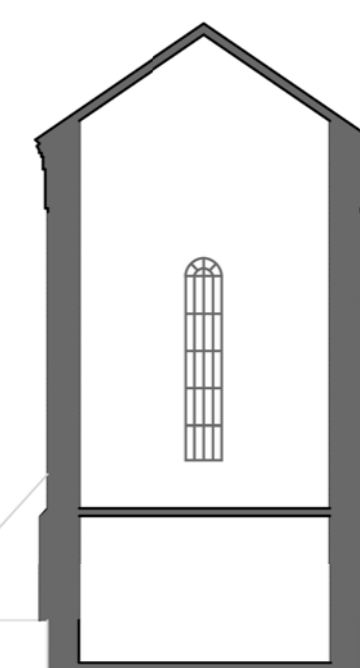

SECTION A-A @SCALE 1:200

REVISION: A	DATE: 01.03.15
WILLIAM J. LINNELL N0338129 DESIGN COMMUNICATION	
PROJECT: STAIR PROJECT Bracebridge Pumping Station Nottinghamshire, S80 2DW	
DRAWING: EXISTING PLANS, SECTIONS ...	
DRAWN BY: WJL	
SCALE : 1:100, 1:200 & 1:1250 @ A 2	
DRAWING NO. : A 1 . A	

DO NOT SCALE FROM THIS DRAWING CHECK ALL MEASUREMENTS ON SITE